


### ELECTRICAL LEGNEND – (INTERIOR)

- NOTE: DASHED SYMBOLS INDICATE EXISTING DEVICES AND EQUIPMENT, UON.  
SYMBOL DESCRIPTION
- FLUORESCENT FIXTURE (TYP.)
  - FLUORESCENT FIXT. WITH EMERGENCY BATTERY PACK
  - WALL MOUNTED EXIT SIGN (SINGLE FACE)
  - WALL MOUNTED EXIT SIGN (DOUBLE FACE)
  - FIXTURE SYMBOL
  - SINGLE POLE SWITCH
  - BRANCH CIRCUIT OR FEEDER WIRING IN CONDUIT. NO TICK MARKS INDICATE 2#12 CONDUCTORS & 1#12 GND. IN 1/2" CONDUIT UON TICK MARKS, WHEN SHOWN, INDICATE NUMBER OF #12 CONDUCTORS IF OTHER THAN THREE; (✓) INDICATES GROUND. CONDUIT LARGER THAN 1/2" & WIRE LARGER THAN #12 SHALL BE AS INDICATED.
  - INDICATES A CONDUIT RUN CONCEALED IN CEILING, WALL, FLOOR, OR ABOVE SUSPENDE CEILING UON.
  - NORTH ARROW
  - JUNCTION BOX. SIZE 6"x6"x4".
  - NEW WORK NOTE
  - DEMOLITION NOTE
  - REMOVE BACK TO THIS POINT
  - CONNECT NEW TO EXISTING

### DEMOLITION NOTES:

- ① REMOVE EXISTING SELF-LUMINOUS EXIT LIGHT COMPLETE, DELIVER TO AND TURN OVER TO THE NEWPORT NEWS VIRGINIA FACILITIES MANAGER.

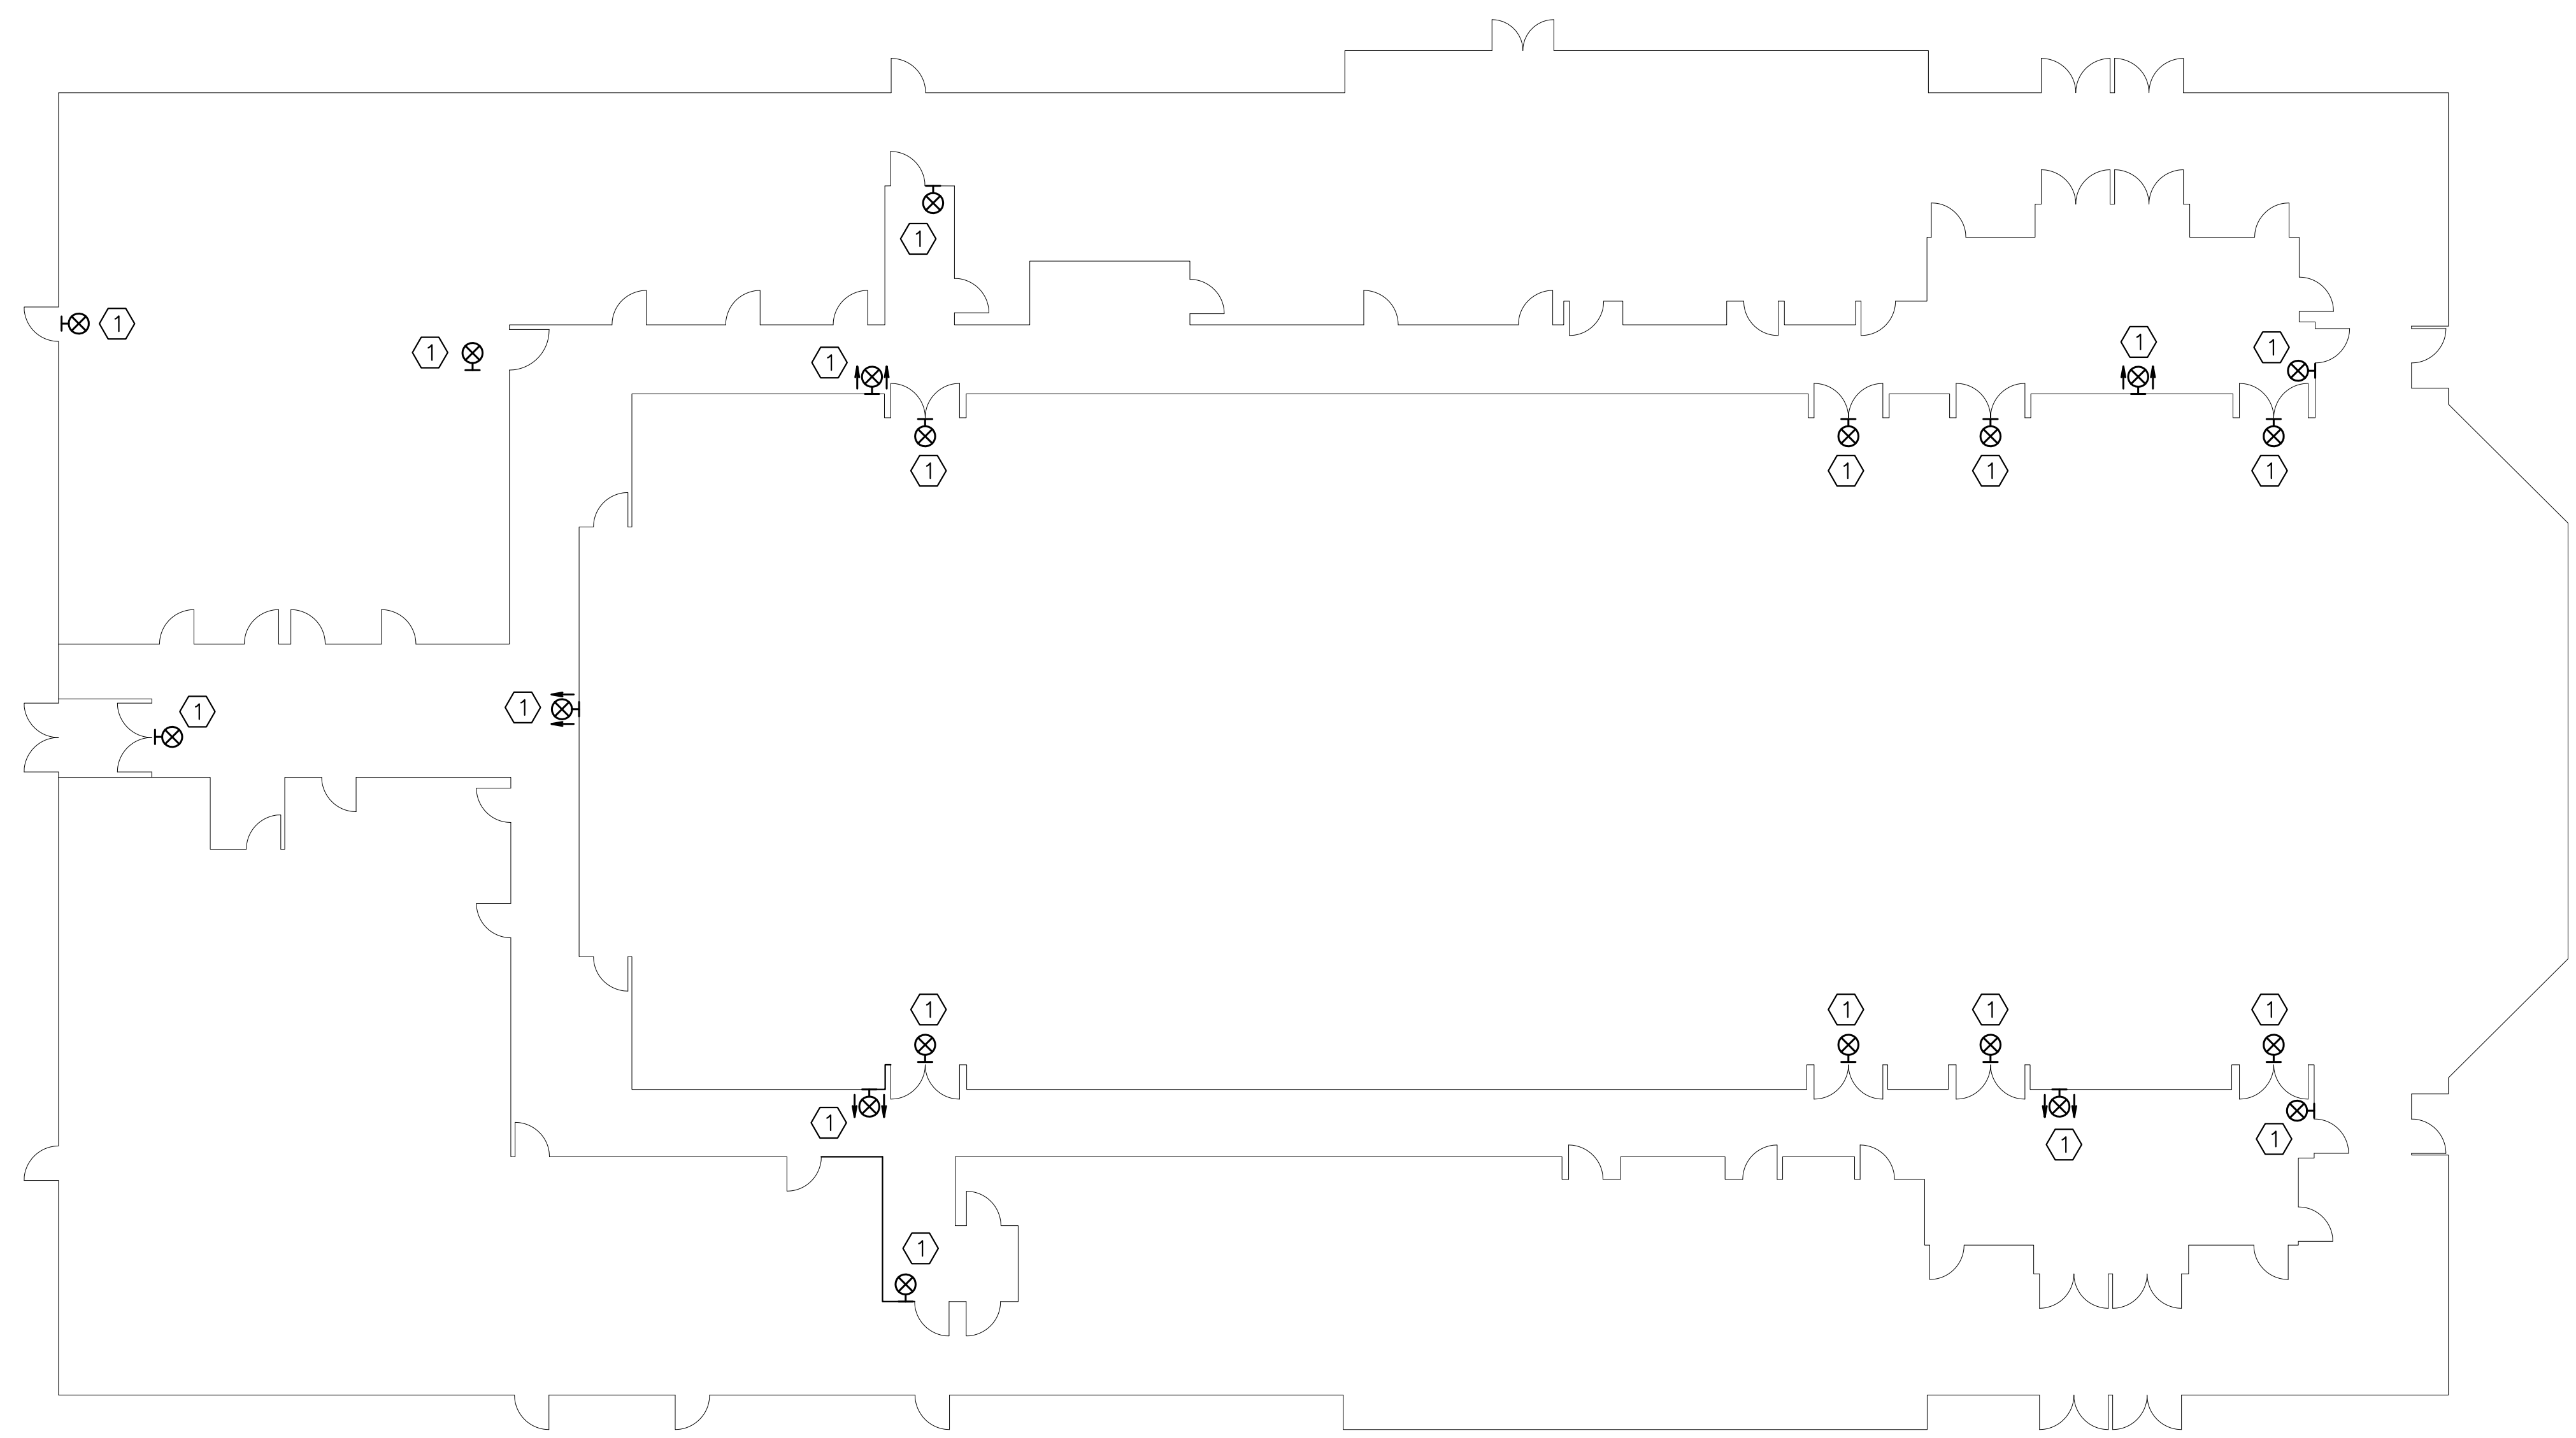

**FLOOR PLAN LIGHTING – DEMOLITION**  
SCALE: 3/32" = 1'-0"

NO.	REVISIONS

**Aisbrook Consulting Engineers**  
5304 Fitchell Ct. Va. Beach, Va. 23452  
T. 757-515-5552

**BENNETTS CREEK WARD AND STAKE CENTER**  
CHESAPEAKE VIRGINIA STAKE  
4799 BENNETTS PASTURE ROAD  
SUFFOLK, VIRGINIA

**EXIT LIGHT REPLACEMENT PROJECT**  
ELECTRICAL FIRST FLOOR PLAN –  
DEMOLITION AND ELECTRICAL LEGEND

DRAWN BY: SCW  
CHECKED BY: GDA

PROPERTY NUMBER

DEVELOPMENT NUMBER

SHEET NO.  
**E1.1**

REVISIONS

**ACE**  
5304 FIGHTHILL CT  
T. 757-515-5552  
Va. Beach, Va. 23452

**BENNETTS CREEK WARD  
AND STAKE CENTER**  
CHESAPEAKE VIRGINIA STAKE  
4799 BENNETTS PASTURE ROAD  
SUFFOLK, VIRGINIA

**EXIT LIGHT REPLACEMENT PROJECT**  
FLOOR PLAN LIGHTING - NEW WORK


DRAWN BY: SCW  
CHECKED BY: GDA

PROPERTY NUMBER

DEVELOPMENT NUMBER

SHEET NO.

**E1.2**

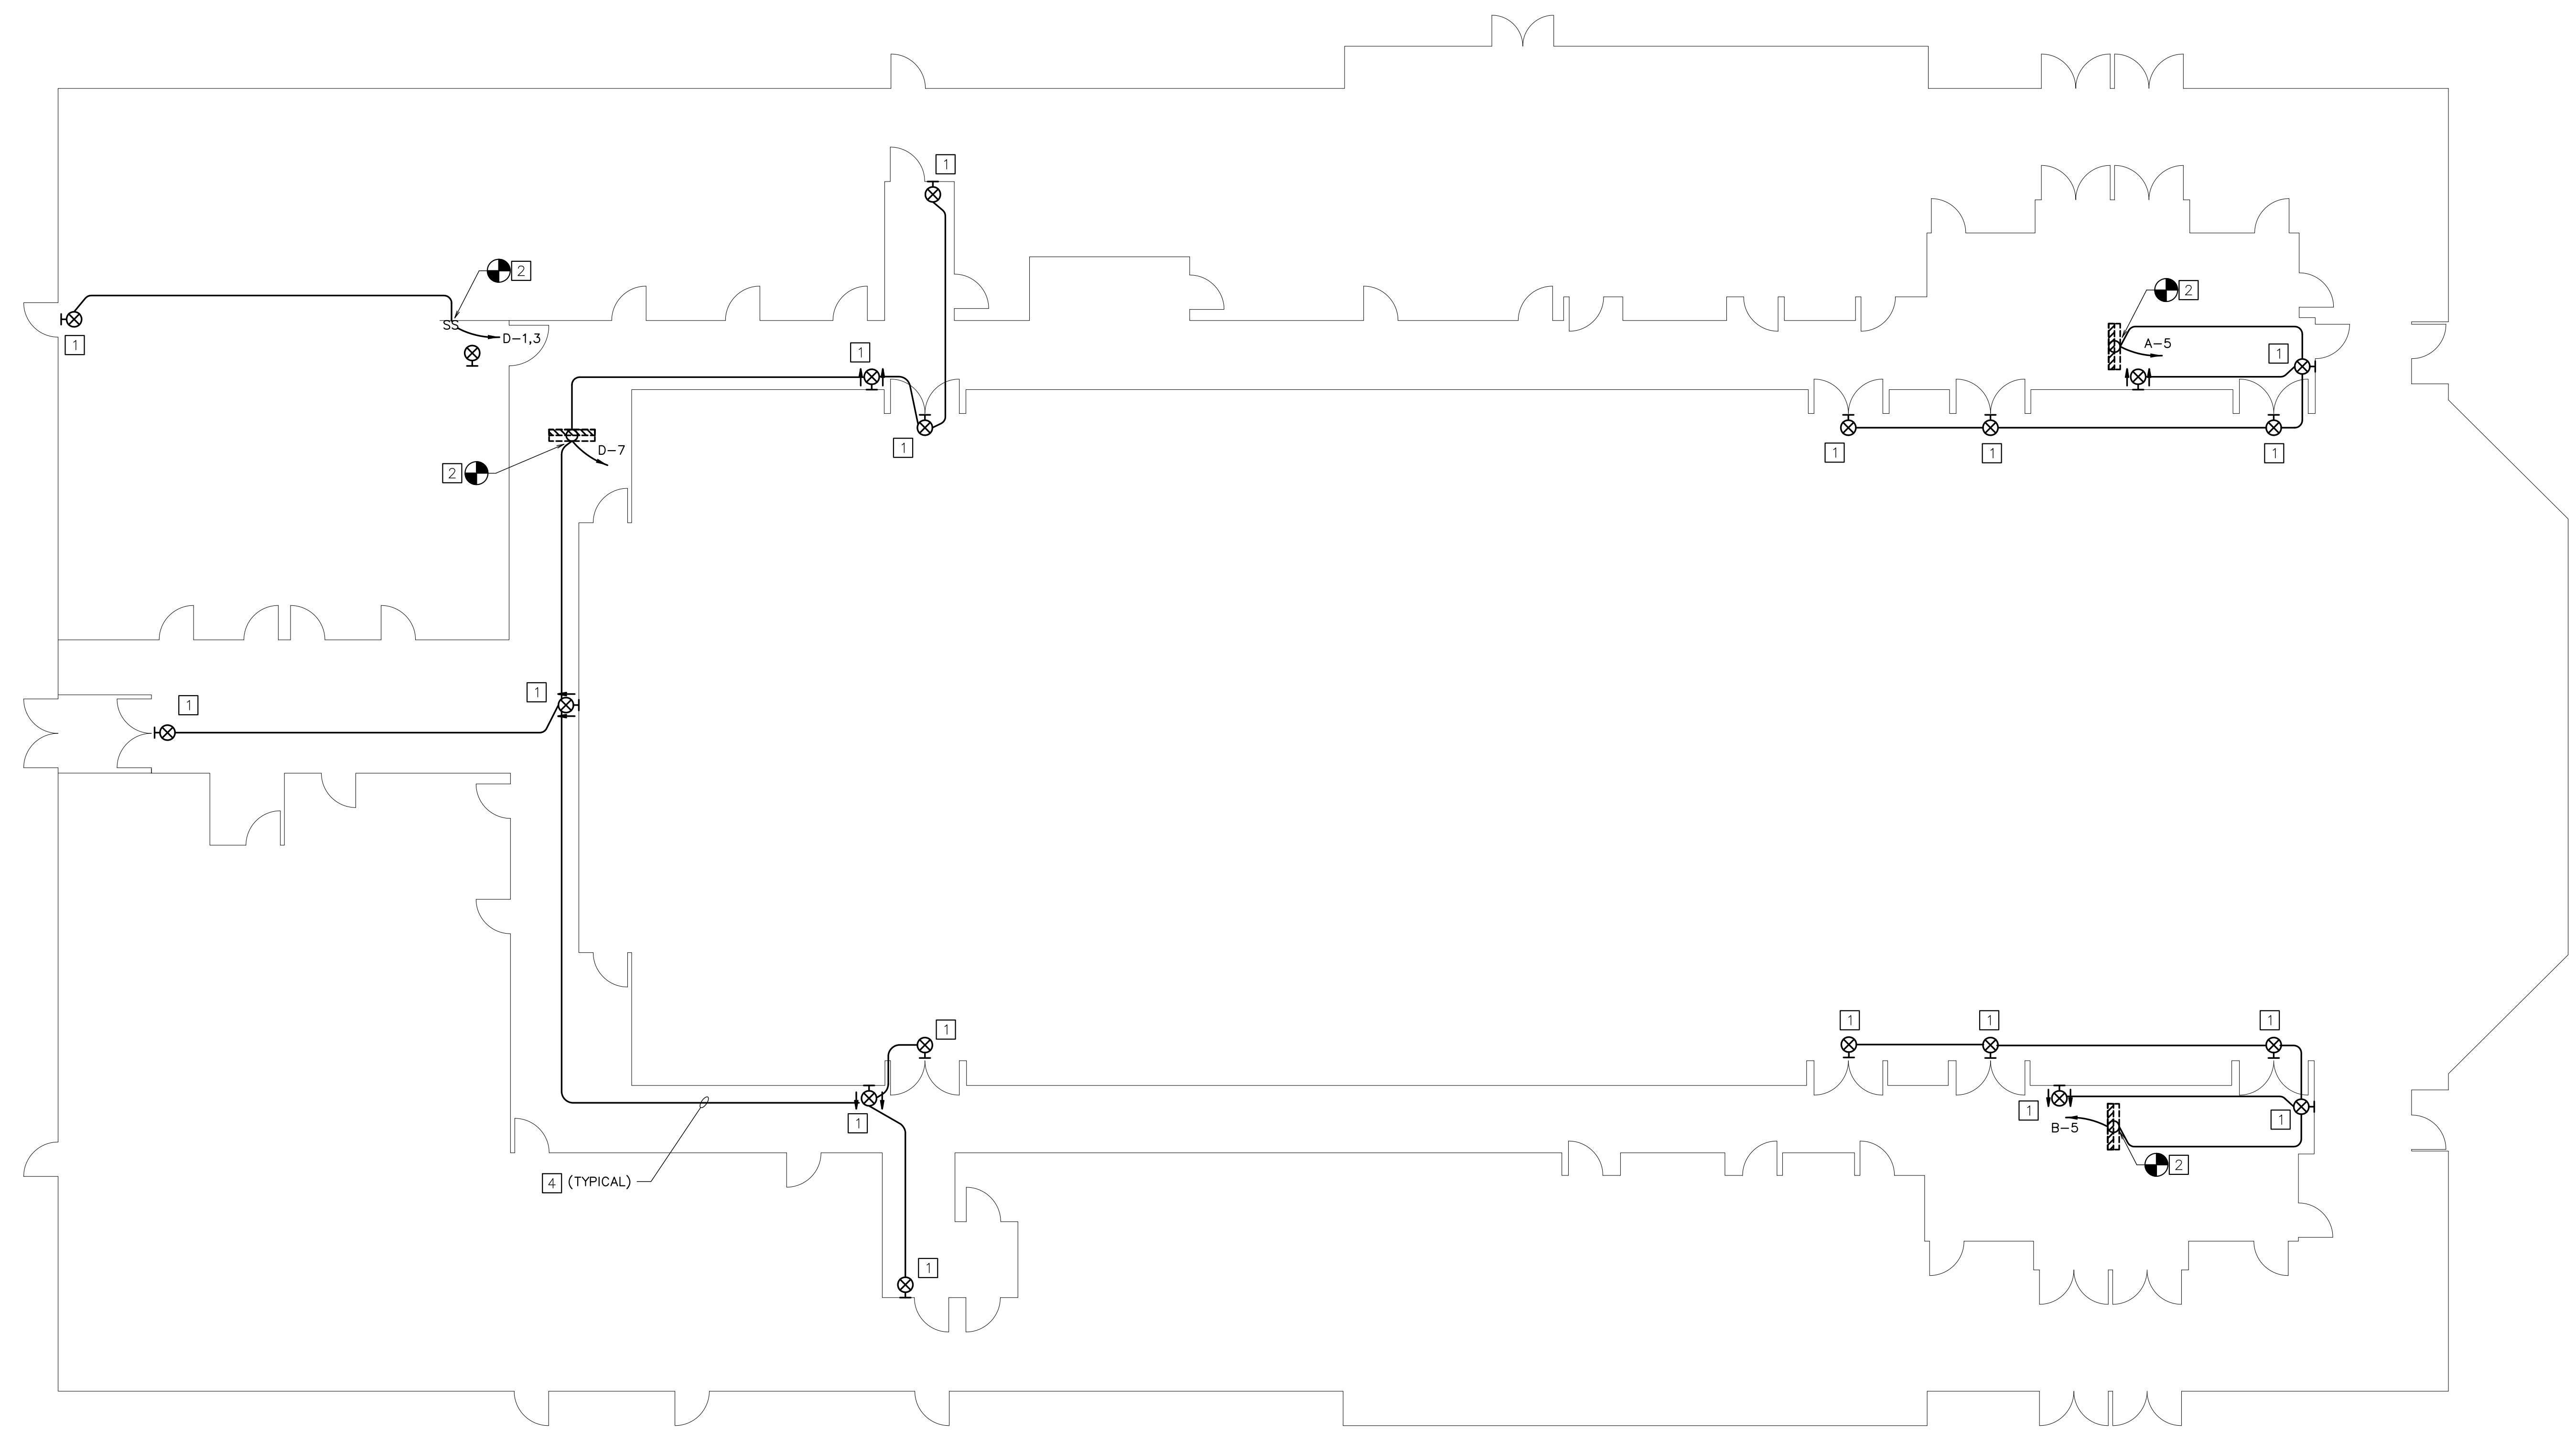

**FLOOR PLAN - LIGHTING - NEW WORK**  
SCALE: 1/8" = 1'-0"

**NEW WORK NOTES:**

- 1 PROVIDE ELECTRICAL POWERED EXIT LIGHT TYPE AS INDICATED. INSTALL IN SAME LOCATION AS PREVIOUS EXIT LIGHT.
- 2 CONNECT TO EXISTING 120 VAC LIGHT CIRCUIT THIS AREA AHEAD OF LOCAL SWITCHING.
- 3 PROVIDE ALL CONDUITS CONCEALED ABOVE CEILING OR IN WALLS.
- 4 RUN ALL CONDUITS CONCEALED. RUN ALL ABOVE CEILING.

FIXTURE SCHEDULE						
SYM	MANUFACTURER		FIX. VA	LAMP TYPE	MOUNTING	REMARKS
	NAME	CAT. NO.				
EXIT	MCPHILBEN	CXXL-3-G-W	5	LED INCLUDED	WALL OR CEILING	PROVIDE DIRECTIONAL ARROWS AS SHOWN ON PLANS. PROVIDE CLEAR VANDAL SHIELD FOR FIXTURES IN CULTURAL CENTER.
	BEGHELLI	VA4-G-SA-AT				
	EXITRONIX	GVEX-U-BP-WB-WH-G2				
	LSI	EX-G-U-WB-WH-SD2				
	ISOLITE	RLEMGWSD				
	SURE-LITES	LPX7-G SD				